




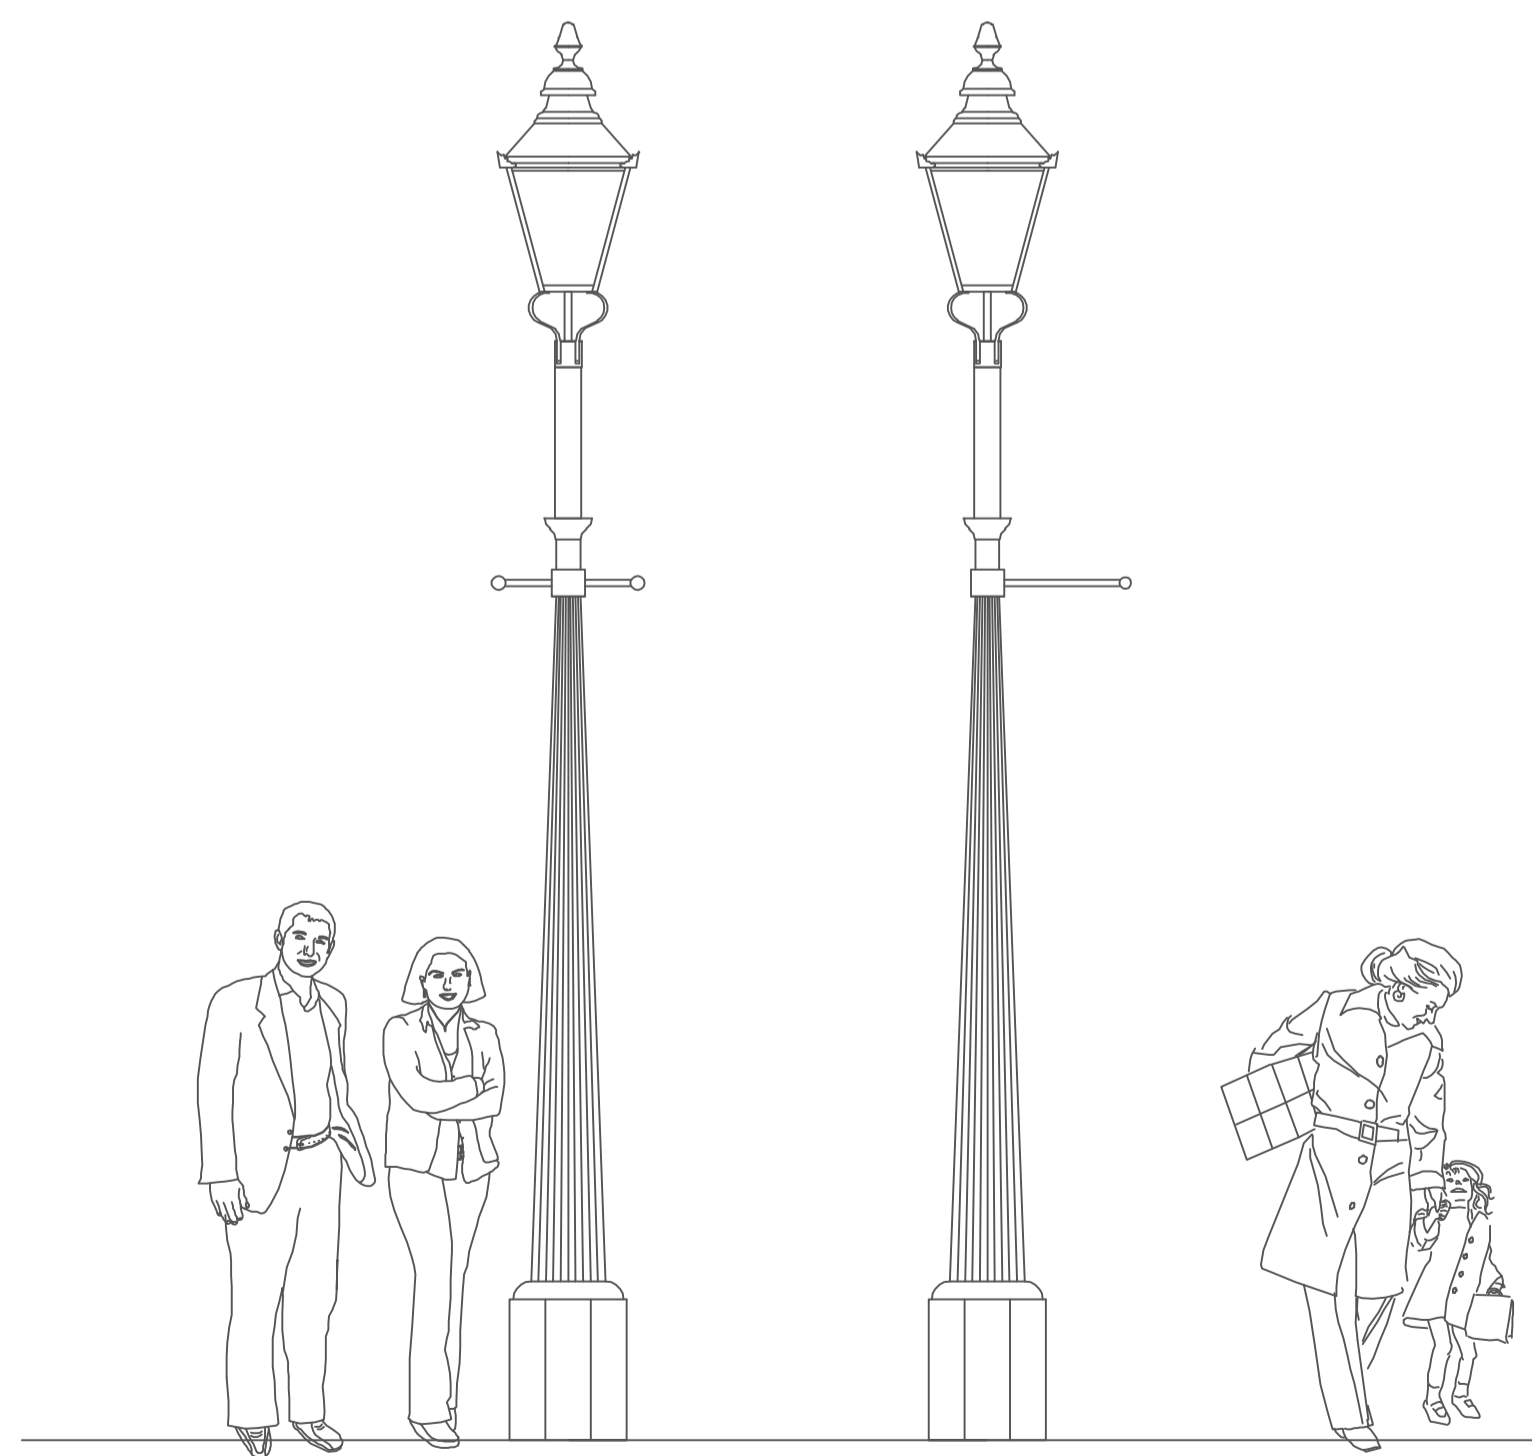
SCALE 1:500 - LAYOUT

-  EXISTING CAST IRON LIGHTING COLUMN TO BE REFURBISHED AND FITTED WITH NEW VICTORIAN STYLE 'DICKENS' LANTERN INCORPORATING A WARM WHITE LED 'GAS MANTLE'. COLOUR BLACK
-  EXISTING WALL MOUNTING TO BE REFURBISHED AND FITTED WITH NEW VICTORIAN STYLE 'DICKENS' LANTERN INCORPORATING A WARM WHITE LED 'GAS MANTLE'. COLOUR BLACK.
-  PROPOSED REFURBISHED FLUTED CAST IRON LIGHTING COLUMN FITTED WITH NEW VICTORIAN STYLE 'DICKENS' LANTERN INCORPORATING A WARM WHITE LED 'GAS MANTLE'. COLOUR BLACK.

NOTES

EXISTING CAST IRON COLUMNS TO BE REFURBISHED ON SITE BY SPECIALIST CONTRACTOR. CLEAR, ALL ROUND, ACCESS TO COLUMN WILL BE REQUIRED DURING REFURBISHMENT WORK RESULTING IN SOME DISRUPTION OF PARKING IN THE IMMEDIATE VICINITY.

PROPOSED REFURBISHED CAST IRON COLUMN WILL BE PROVIDED WITH TWO LADDER BAR OPTIONS, SINGLE AND TWIN AS SHOWN IN DETAIL BELOW. THESE SHALL BE RANDOMLY LOCATED THROUGHOUT WORKS.



SCALE 1:25 - PROPOSED LIGHTING COLUMNS

1	02/19	Positions amended	MP	IWH
Rev. No.	Date	Amendments	Initials Made	Initials Chk.
Scale: AS SHOWN		Date: DECEMBER 2018		
Drawn	MP			
Checked	SMcL			
Approved	IWH			
Job: ROAD LIGHTING IMPROVEMENTS FRONT STREET - ALSTON				
Title: PROPOSED ROAD LIGHTING LAYOUT				
Client: INTERNAL				
Drawing No. ED-014-01-Am1				



Parkhouse Building, Kingmoor Business Park
CARLISLE, Cumbria, CA6 4SJ. Tel: 01228 673030

Reproduced from, or based on, Ordnance Survey Map material with the permission of the Controller of Her Majesty's Stationery Office. (c) Crown Copyright 2006. Licence number 100019596 Cumbria County Council. Unauthorised reproduction infringes Crown copyright and may lead to prosecution or civil proceedings.