

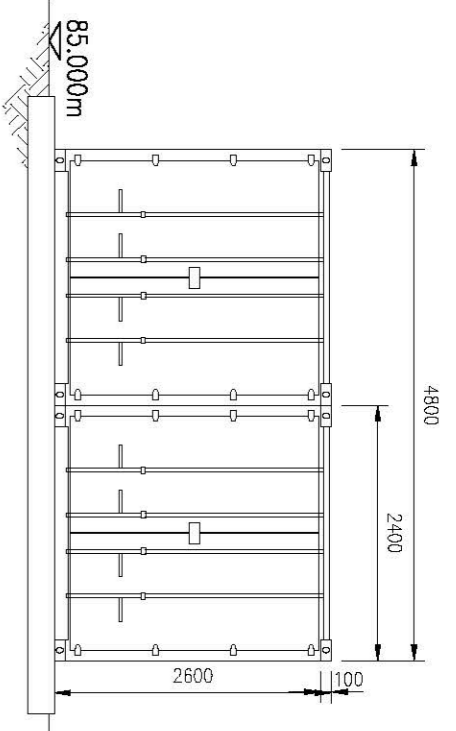



Section Through Compound
Scale 1:200

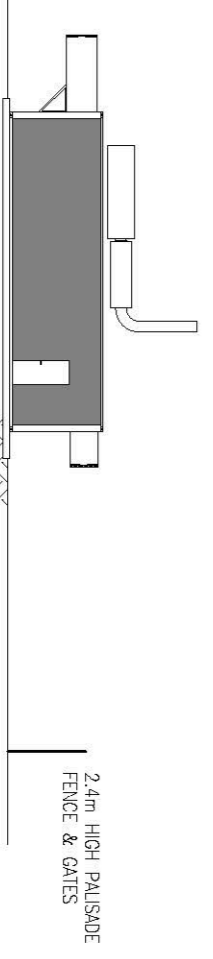


Elevations on HV Room
Scale 1:50

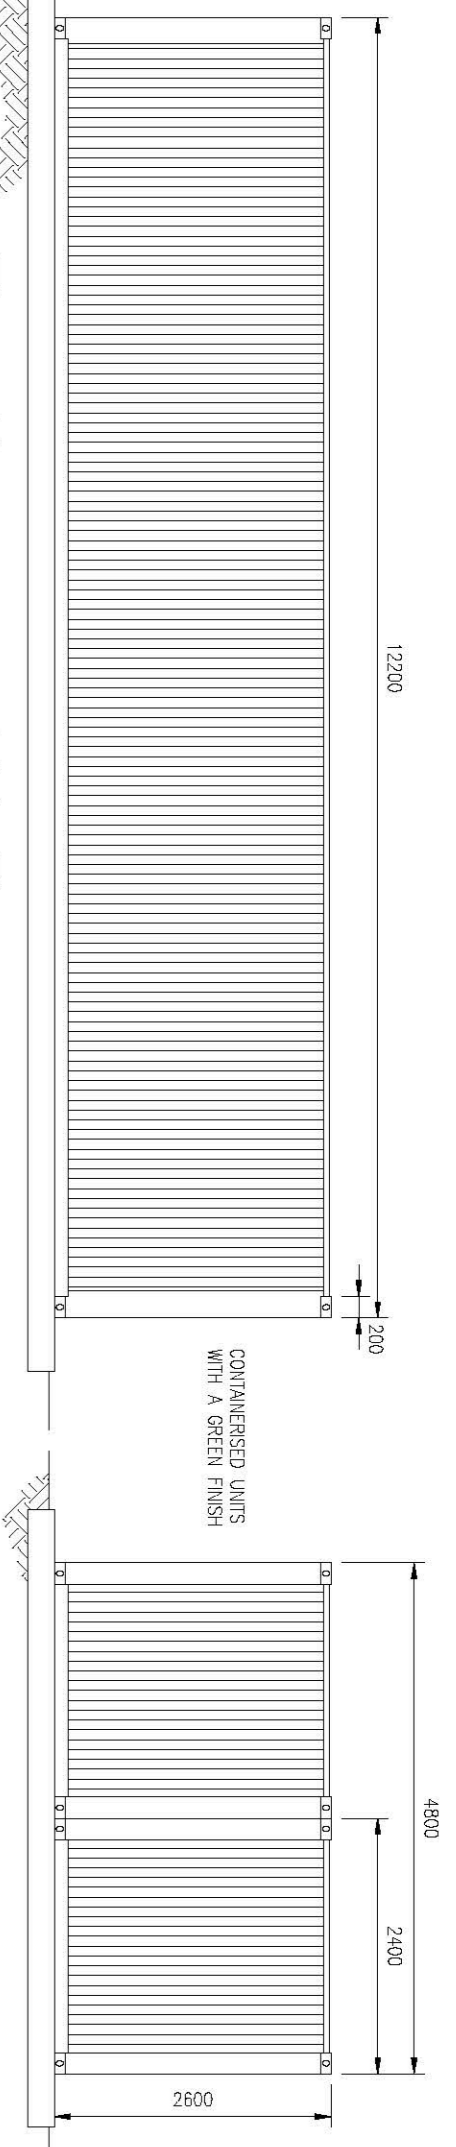




Elevations on LV Room
Scale 1:50

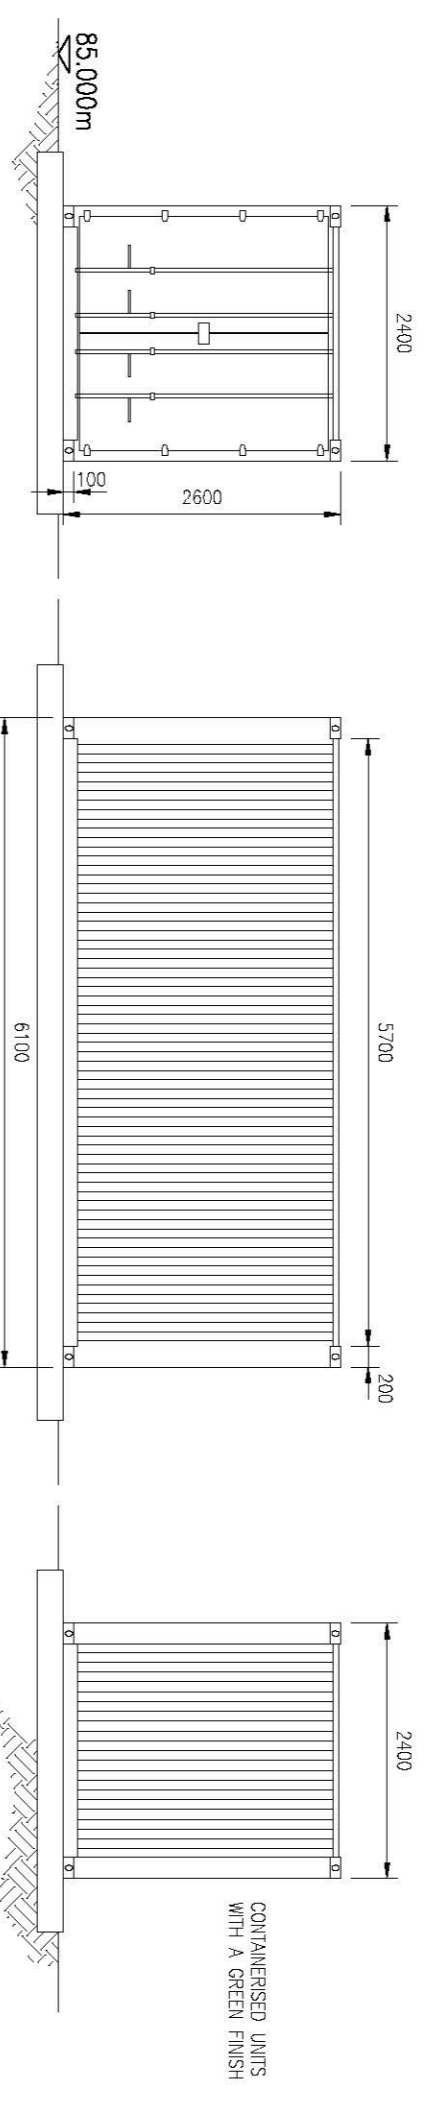

Elevations on Gas Engine Container
Scale 1:50

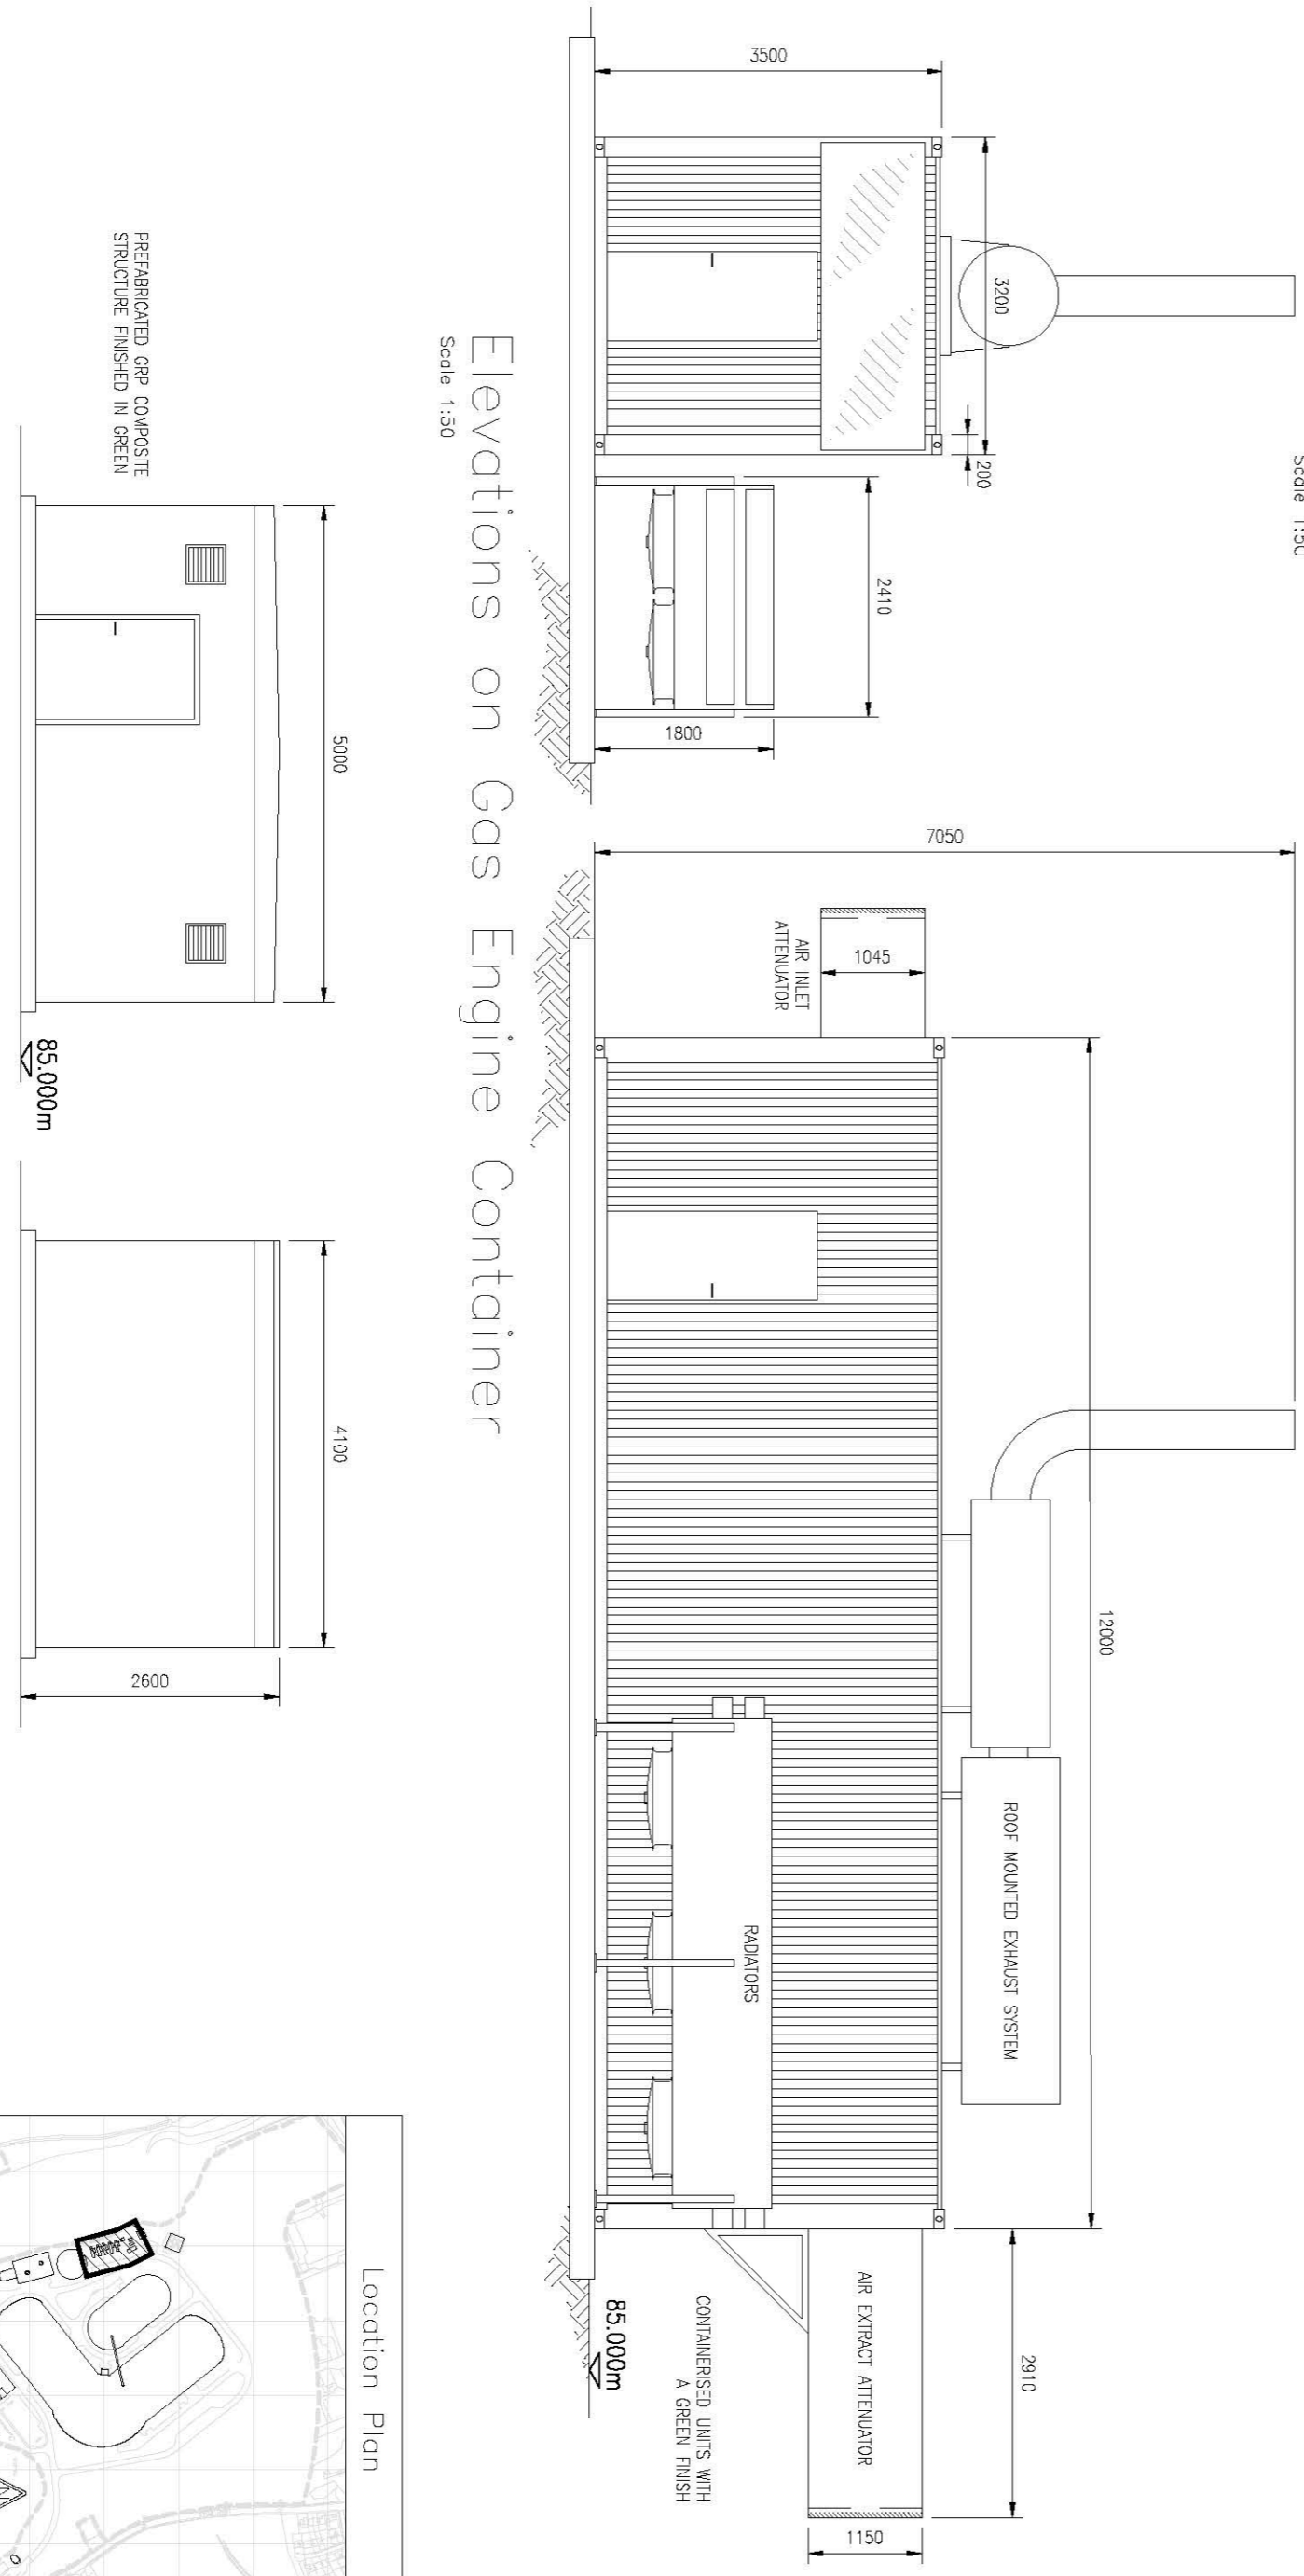

Elevations on Gas Monitoring Kiosk
Scale 1:50

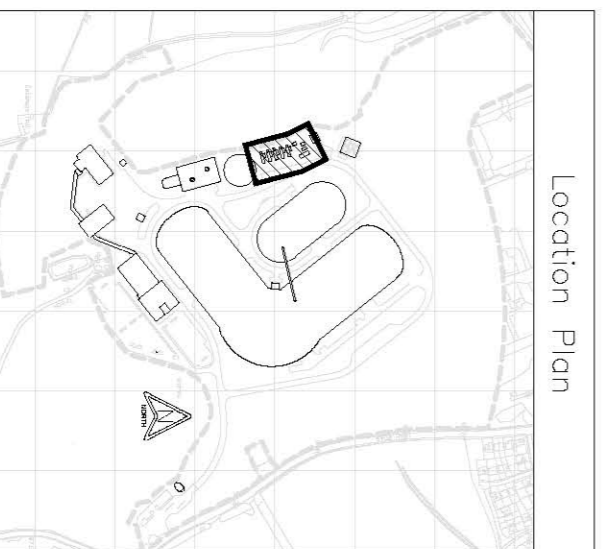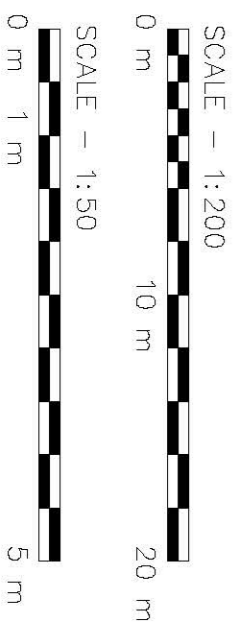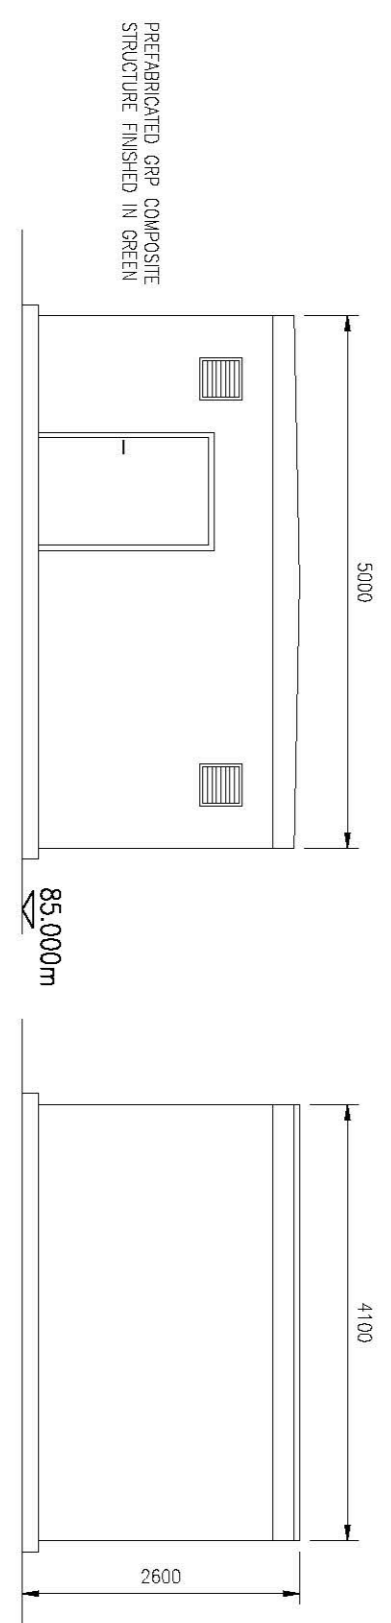

Cumbrian Metallurgical Coal Project
869/AM/021
Main Mine Site
Auxiliary Power Plant - Gas
Proposed Plan & Elevations

Date: MAY 2017
By: MRL
Paper: A1
Scale: AS SHOWN
Rev: LV
A