




Plan on Diesel Generator Building
Scale 1:50

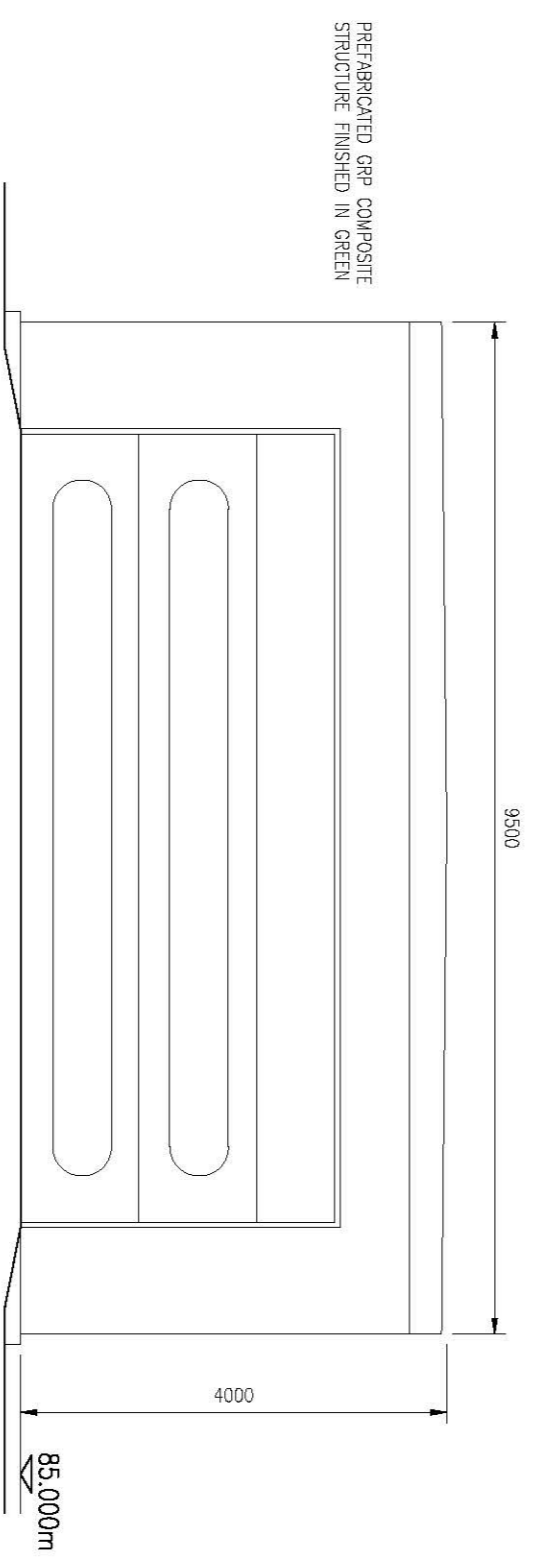



South East Elevation
Scale 1:50

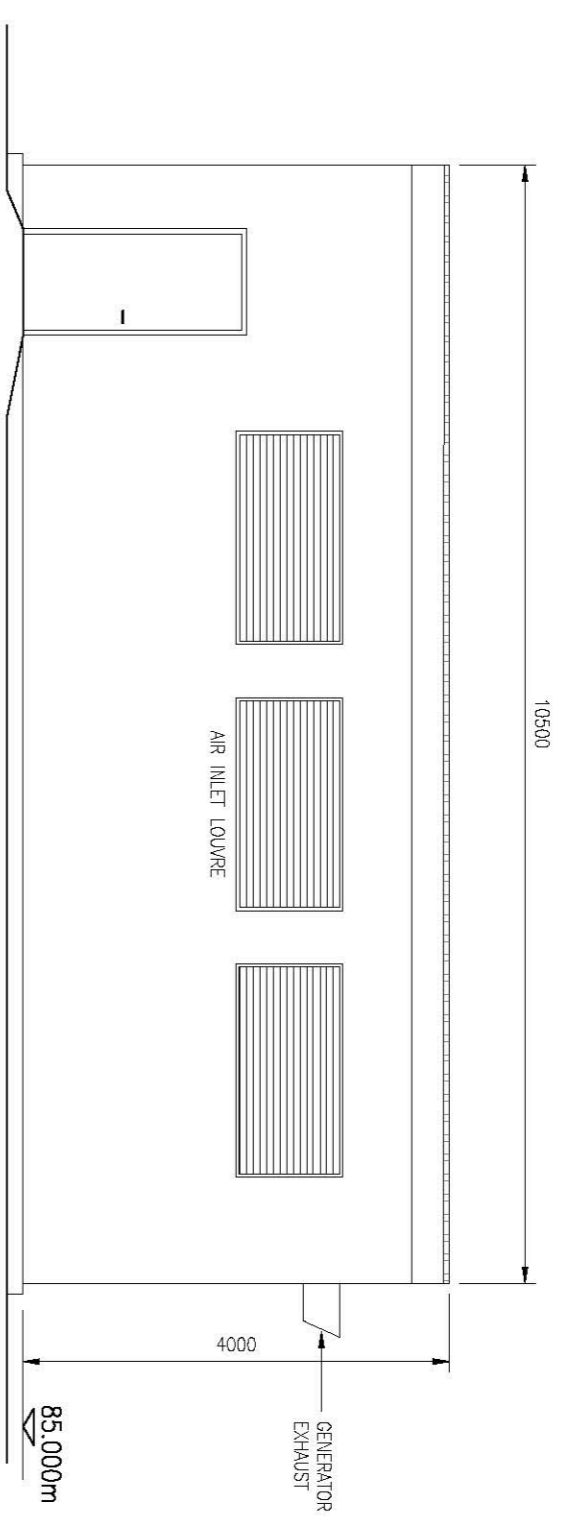

South West Elevation (North East Similar)
Scale 1:50

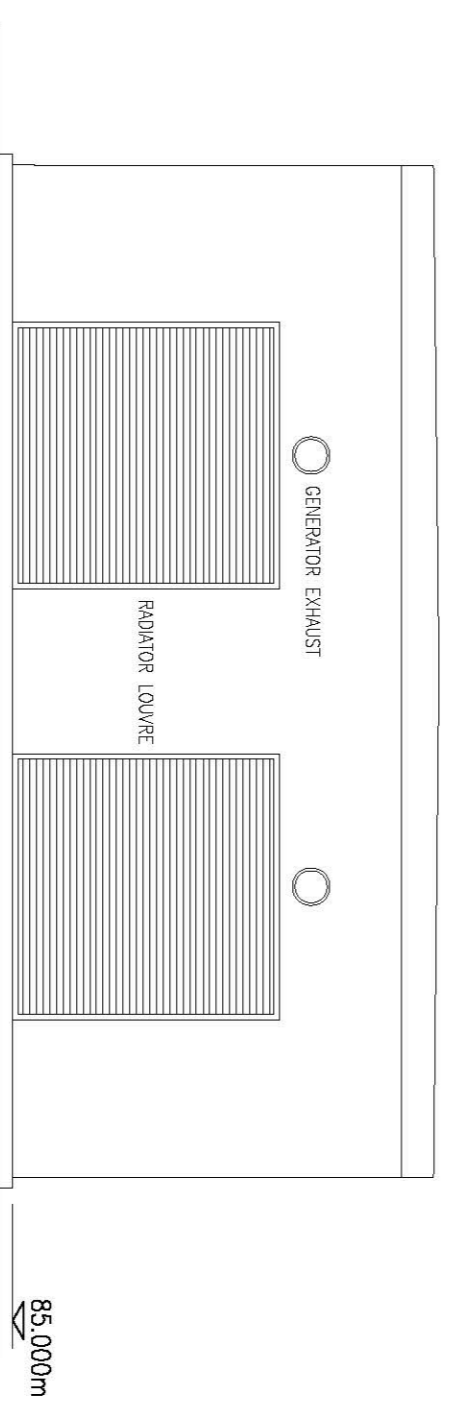

North West Elevation
Scale 1:50

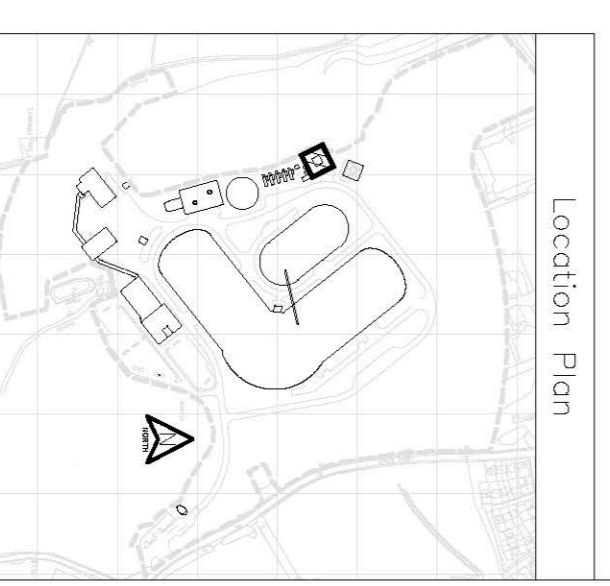 

Location Plan

Cumbrian Metallurgical Coal Project

869/AM/023

Main Mine Site
Auxiliary Power Plant – Diesel
Proposed Plan & Elevations

Date	By	Paper	Scale	QA	Rev
MAY 2017	MRH	A1	1:50	LV	A

